


- FLAG NOTES:**
- 1 PROVIDE MANHOLE CONNECTION PER DETAIL 2/C002
  - 2 NOT USED
  - 3 SEE DETAIL 1/C002 FOR TYPICAL MANHOLE PLAN AND SECTION
  - 4 SEE DRAWING C106 FOR INFLUENT PUMP STATION MODIFICATION PLAN, AND SECTION.
  - 5 CONSTRUCT NEW WAS FEED, SEE DETAIL 4/M006
  - 6 INSTALL METERING MANHOLE, SEE DETAIL 2/C106
  - 7 CONNECT TO EXISTING SOLIDS FEED PIPING TO DEWATERING PRESS, AS REQUIRED IN BUILDING, SAWCUT REMOVE AND REPLACE CONCRETE.
  - 8 CONSTRUCT NEW TELESCOPING VALVE FOR DECANT, SEE DETAIL 3/M006
  - 9 SEE SHEETS M424 AND M426 FOR 16" FE PIPING WITHIN BUILDING LIMITS
  - 10 CONTRACTOR TO INSTALL 16" FE 90 DEG BENDS TO CREATE A NEW 16" FE, IE OF 22.00
  - 11 CONNECT TO EXISTING 10" FE AT APPROXIMATE ELEVATION OF 18.20
  - 12 SEE SHEET M226 FOR D PIPING WITHIN BUILDING LIMITS
  - 13 SEE SHEET M424 FOR 6" SL PIPING WITHIN BUILDING LIMITS
  - 14 TRANSITION FROM DUCTILE IRON PIPE (WITHIN BUILDING) TO PVC C905 PIPE JUST DOWNSTREAM OF 90 DEGREE ELBOW AT APPROXIMATE ELEVATION OF 22.00. REFER TO PIPING SCHEDULE ON SHEET M001
- NOTES:**
1. REFER TO TYPICAL DETAIL 1/C001 FOR ALL PIPE TRENCH DETAILS.
  2. REFER TO GENERAL PIPING NOTES ON SHEET C102

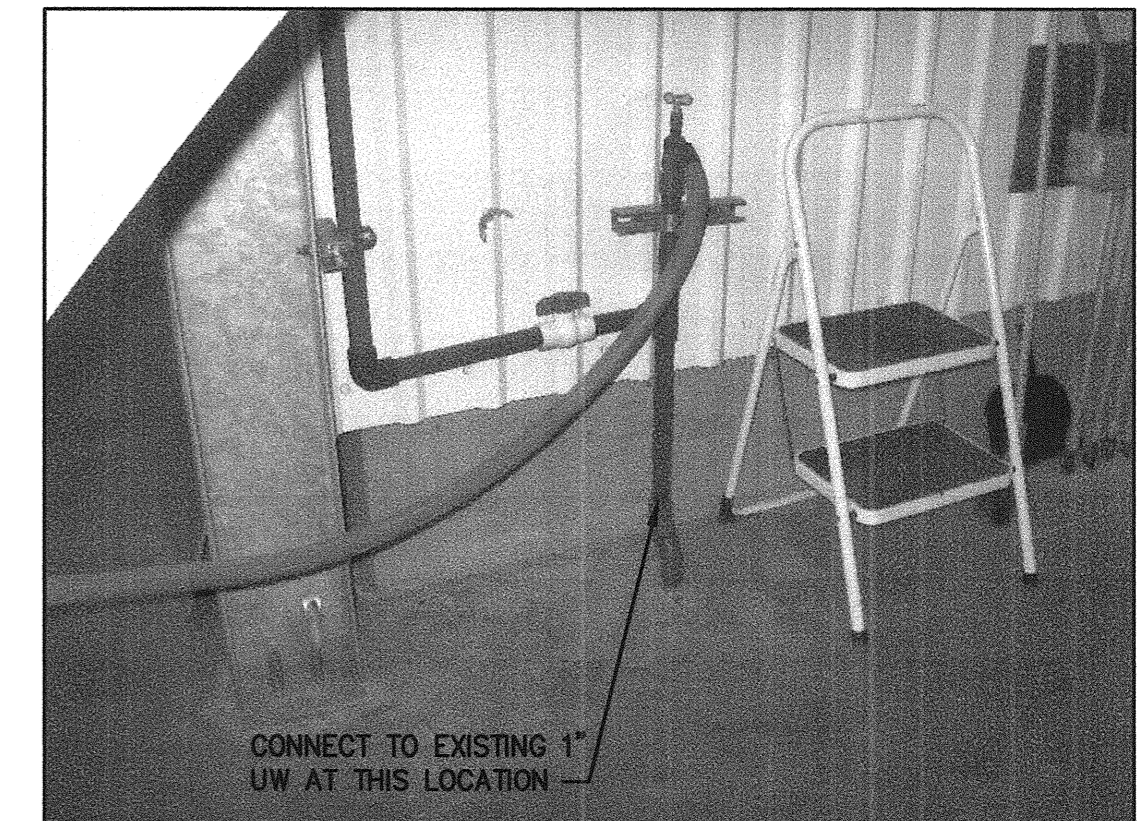

**1 BIOSOLIDS HANDLING BLDG UW CONNECTION**  
 C104 SCALE: NTS

**USE OF DOCUMENTS**  
 THIS DOCUMENT, INCLUDING THE INCORPORATED DESIGNS, IS AN INSTRUMENT OF SERVICE FOR THIS PROJECT AND SHALL NOT BE USED FOR ANY OTHER PROJECT WITHOUT THE WRITTEN AUTHORIZATION OF KENNEDY/JENKS CONSULTANTS.

| NO. | REVISION | DATE | BY |
|-----|----------|------|----|
|     |          |      |    |
|     |          |      |    |
|     |          |      |    |

**SCALES**

0 — 1" = 25mm

IF THIS BAR IS NOT DIMENSION SHOWN, ADJUST SCALES ACCORDINGLY.

DESIGNED: TJA/SEL  
 DRAWN: SEL/TJA  
 CHECKED: JEC/PLVM

CITY OF LA CENTER  
 LA CENTER, WASHINGTON  
**WASTEWATER TREATMENT PLANT  
 PHASE 1 IMPROVEMENTS PROJECT**

Kennedy/Jenks Consultants  
 200 SW MARKET STREET, SUITE 500, PORTLAND, OREGON

**YARD PIPING PLAN - PROCESS  
 PIPING AND BASIN DRAINAGE  
 SYSTEMS**

|           |                |
|-----------|----------------|
| FILE NAME | 0691023-C103   |
| JOB NO.   | 0691023.00     |
| DATE      | SEPTEMBER 2008 |
| SHEET OF  | C103 142       |